

1. PowerPhone
2. Sound Communications
3. SyTech Corporation
4. Southern Software, Inc.
5. A.K. Associates
6. Nelson Systems
7. ERS Wireless
8. Indigital
9. Indigital
10. Thomas Shelby & Co.
11. Futurity
12. Solacom

13. Solacom
14. DataMark
- 15.
16. ER Assist
17. RapidSos
18. ID Networks
19. ID Networks
20. Miller at Work
- 21.
- 22.
- 23.

- 24.
- 25.
26. **KY EM**
27. **KEMA**
28. **KENA / APCO**
- 29.
30. **Ricardo Martinez**
31. Caliber
32. Kenwood
33. Bold Planning
34. Hyper-Reach

35. Tyler Tech
36. Evapar
37. Priority Dispatch
38. Beresford Company
39. Motorola Solutions
40. Motorola Solutions
41. CIS
42. CIS
43. LG & E/KU
44. LG& E/KU
45. Columbia Southern

Kentucky Emergency Service Conference

Ky Emergency Service Conf

2021

Crowne Plaza

Louisville, KY

Crowne Ballroom

Legend:

OUTDOOR
EXHIBITS

Pendleton

71

72


73

74

75

To
Outdoor
Exhibits

Crowne Ballroom

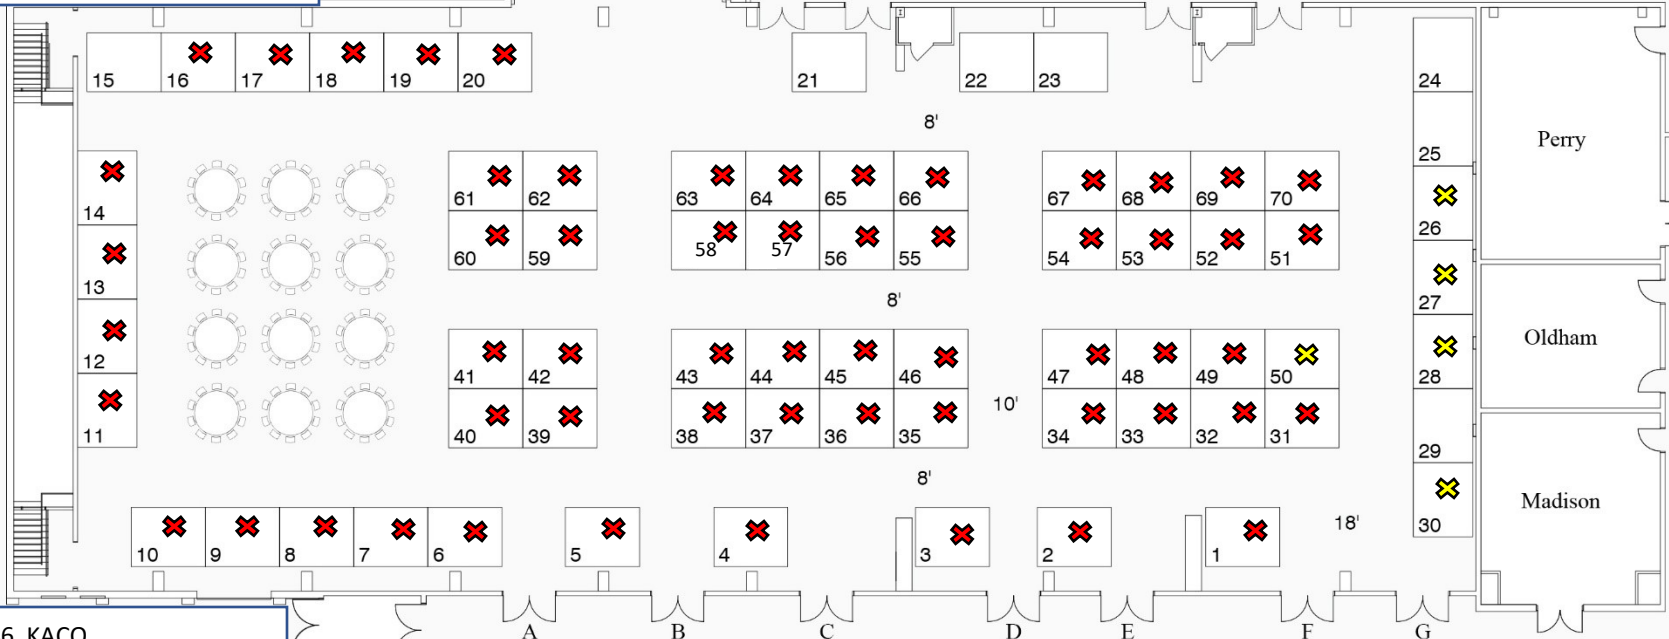

46. KACO
47. VEI Communications
48. Xybix
49. NGA 911
50. **911 Services Board**
51. PEAKE
52. ATT
53. ATT
54. Stephen Campbell
55. Zoll Medical Corp.
56. Unified Solutions
57. Rural Domestic
58. RCS Communications

59. ADS Recorders
60. Federal Signal Corporation
61. GeoComm
62. Omnitronics
63. Rapid Deploy

64. AMK
65. Evans Consoles
66. MapSync
67. Rave
68. Midland Radios

69. Atos Public Safety
- 70.
- 71.
- 72.
- 73.
- 74.
- 75.

AE: Mandy Simpson

Show Number:

Drawn By: M. Ottman

Revised:

File:

Every effort has been made to ensure the accuracy of all information contained on this floor plan. However, no warranties, either expressed or implied are made with respect to this floor plan. If the location of building columns, utilities or other architectural components of the facility is a consideration in the construction of an exhibit, it is the sole responsibility of the exhibitor to physically inspect the facility to verify all dimensions and locations.

fern

3752 Crittenden Drive
Louisville, KY. 40209
502-367-0254